


1 BUILDING PLAN - BASEMENT - SANITARY SEWER PLAN
1/8"=1'-0"

4" GREASE WASTE SERVICE U/G.
INVERT BASED ON 1/4" SLOPE
PER FOOT @ 5.0' OUT FROM
BLDG. LINE. 4.5' B.F.F. COORDINATE WITH
THE CIVIL PLANS FOR THE GREASE TRAP
LOCATION AND CONNECTION

8" SANITARY SEWER SERVICE U/G.
(DEMAND 936 D.F.U.)
INVERT BASED ON 1/8" SLOPE
PER FOOT @ 5.0' OUT FROM
BLDG. LINE. 4.5' B.F.F.

CONSULTANT:
WAHEED CONSULTING
MECHANICAL-ELECTRICAL-PLUMBING SYSTEM DESIGN
Registration No. F-6336
TEL: (817) 793 2010, FAX: (817) 442 4063
420 PARKSIDE ST. MURPHY, TX, 75094
E-mail: waheedmep@yahoo.com

ART HOUSE
3113 NORTH BECKLEY AVE.,
DALLAS, TEXAS

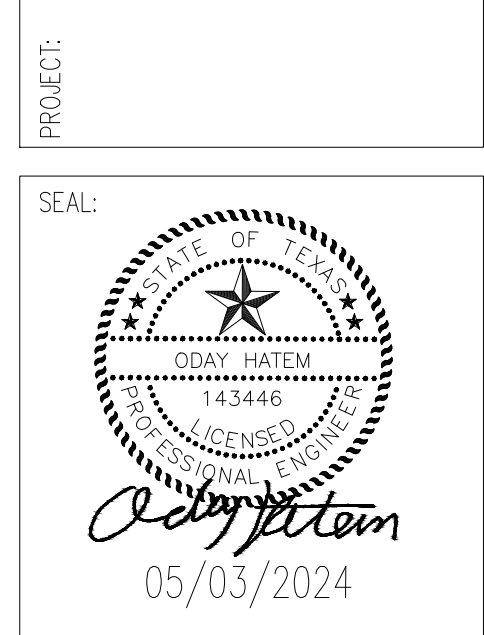

REVISIONS: DATE:
OWNER CHANGES 10/10/2024

TITLE:
**SANITARY PLAN
BASEMENT**

DATE: 04/26/2024 SCALE: 1/8"=1'-0"
DRAWN: O.H. CHECKED: O.H.
PROJECT #
SHEET NO: **P2.01**