


SITE PLAN LEGEND	
	STORM DRAIN U/G
	SANITARY SEWER SERVICE U/G
	DOMESTIC WATER SERVICE U/G
	BFF BELOW FINISH FLOOR

SEWER / WATER KEYNOTES	
(S1)	SEWER BUILDING - : 8"SS, 936 DFU, @1/8" SLOPE, INVERT 4.5' BFF OF BASEMENT LEVEL.
(W1)	WATER BUILDING - 4"CW < 784 WSFU, 178 GPM>
(F1)	ESTIMATED 6" FS.

STORMS KEYNOTES	
(ST-1)	ROOF DRAIN - 12" SD, 27,694 SQFT, @1/8" SLOPE, INVERT 5.0' BFF BELOW BASEMENT LEVEL

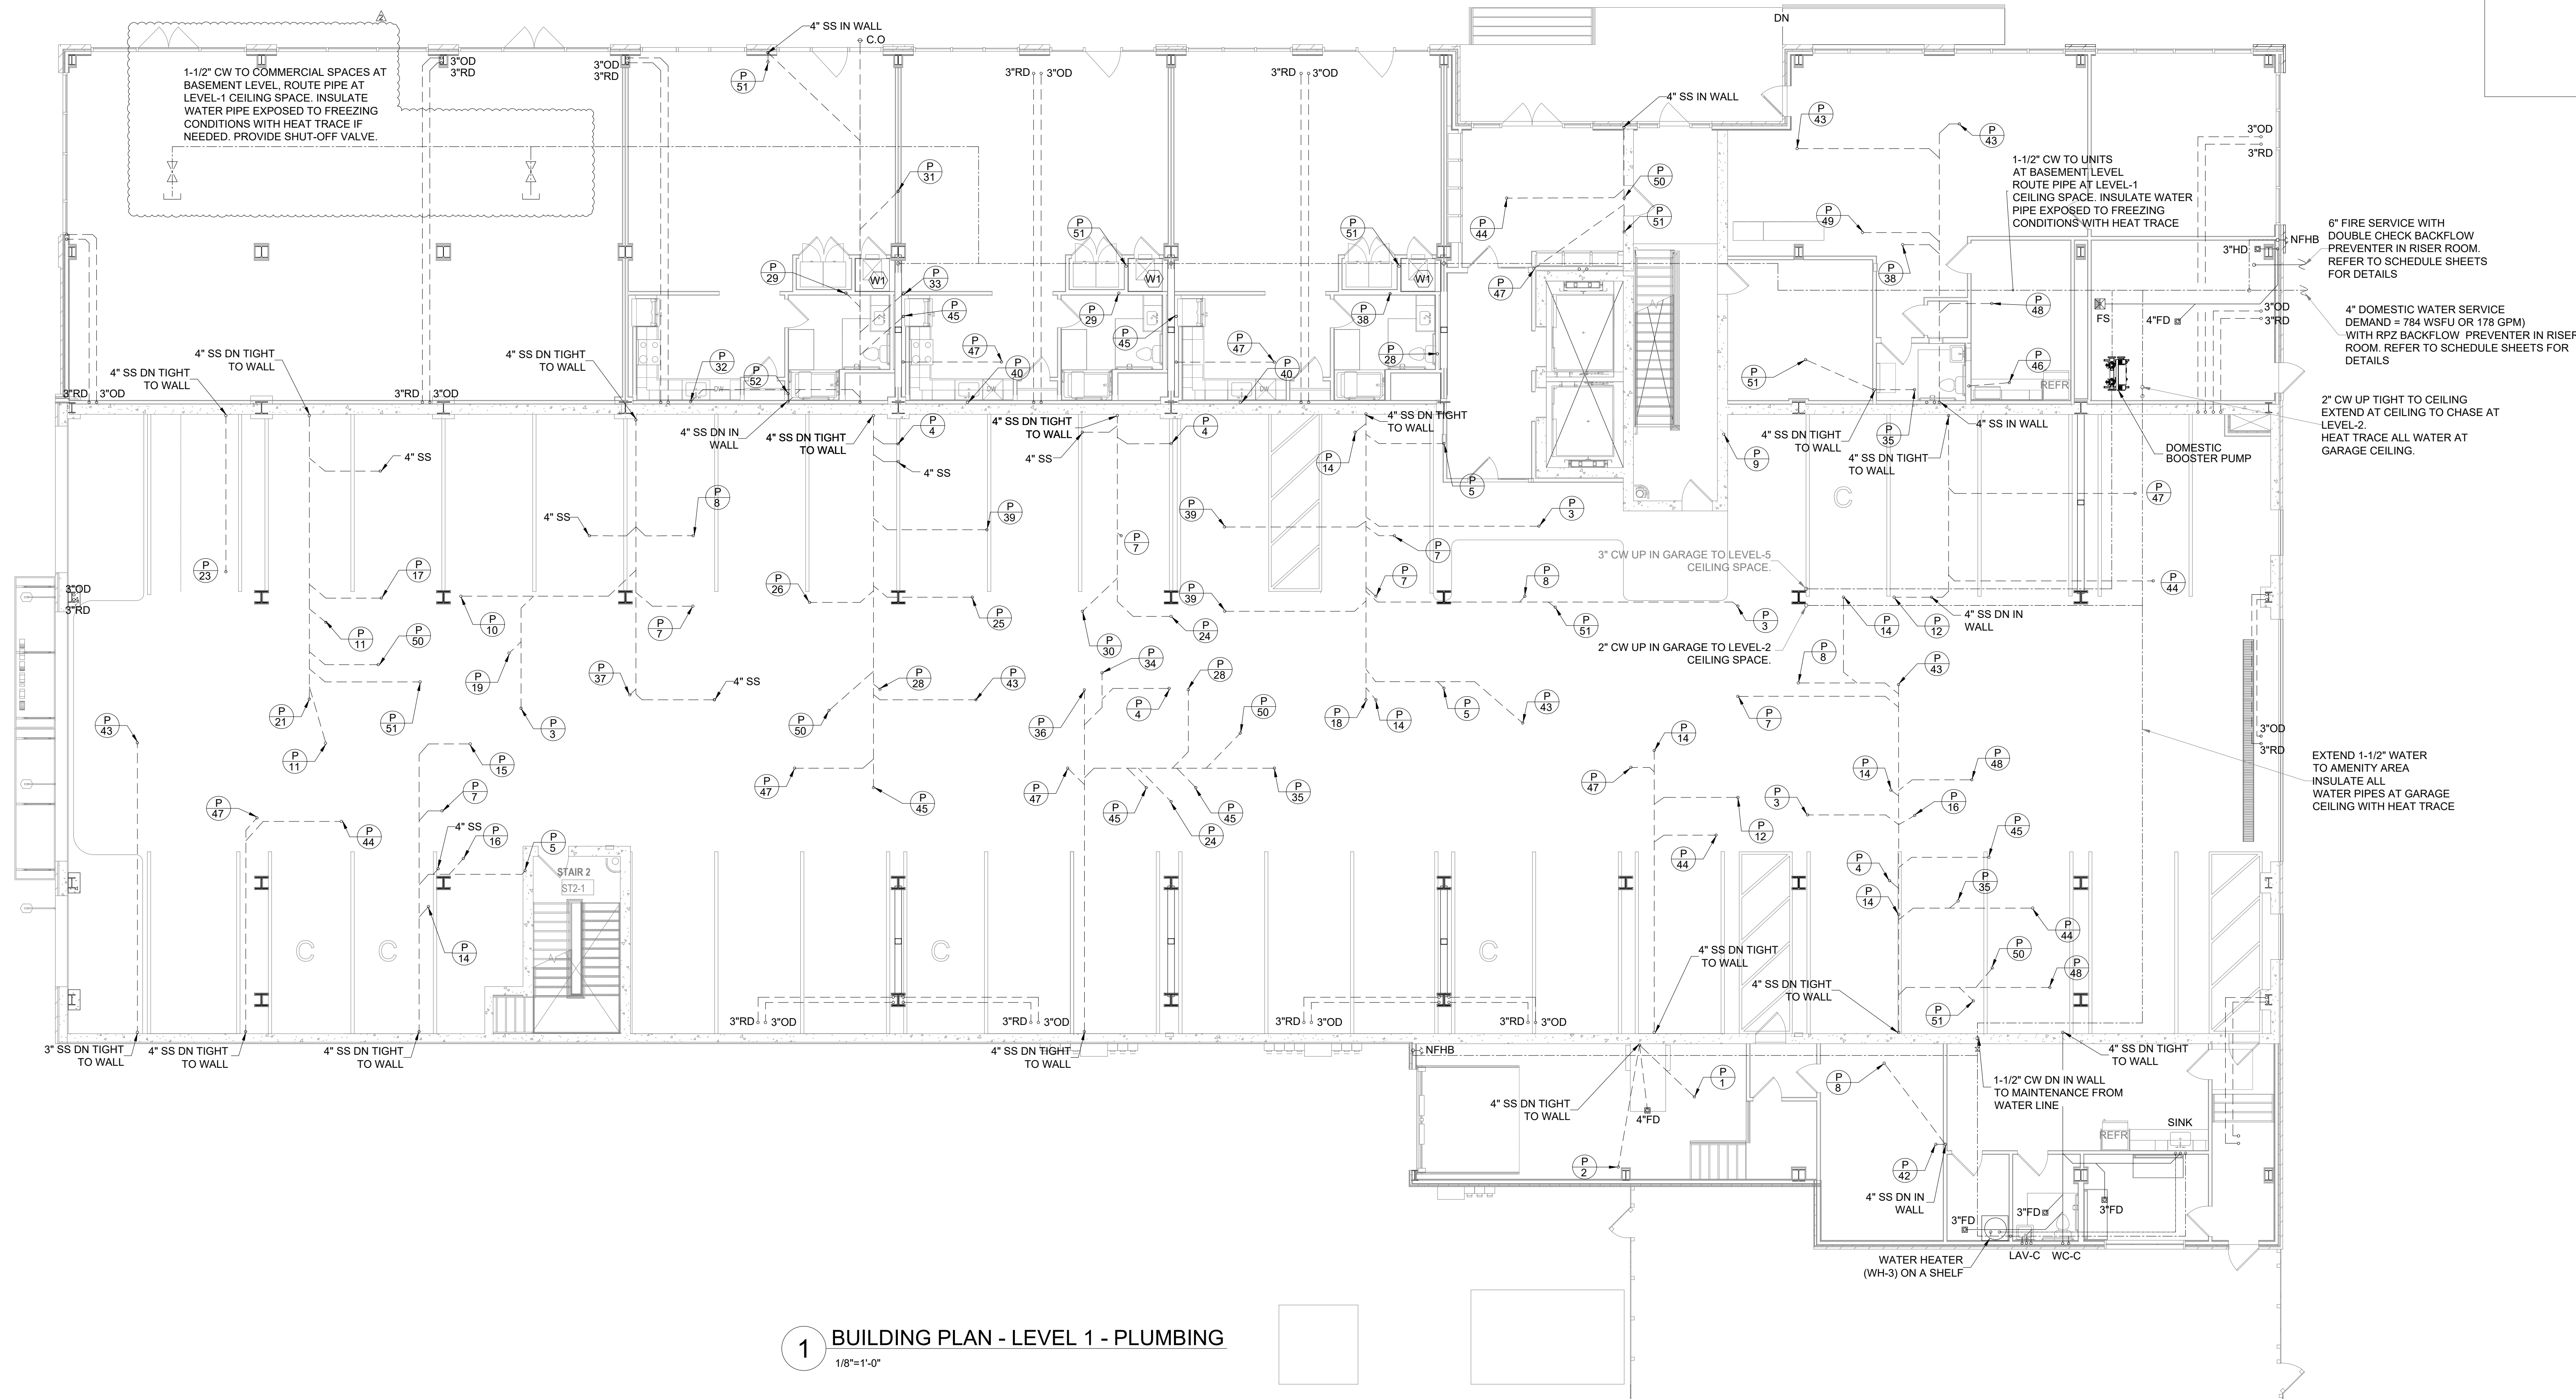

1 BUILDING PLAN - LEVEL 1 - PLUMBING
1/8"=1'-0"

CONSULTANT:
WAHEED CONSULTING
MECHANICAL-ELECTRICAL-PLUMBING SYSTEM DESIGN
Registration No. F-6336
TEL: (817) 783 2010, FAX: (817) 442 4063
420 PARKSIDE ST. MURPHY, TX, 75094
E-mail: waheedmp@yahoo.com

ART HOUSE
313 NORTH BECKLEY AVE,
DALLAS, TEXAS

PROJECT:
SEAL:

05/03/2024

REVISIONS: DATE:
OWNER CHANGES 10/10/2024

TITLE:
**PLUMBING LAYOUT PLAN
LEVEL 1**

DATE: 04/26/2024 SCALE: 1/8"=1'-0"
DRAWN: O.H. CHECKED: O.H.

PROJECT #
SHEET NO: **P2.02**